



Detail 1 - Pocket Park Scale 1:200 @A1

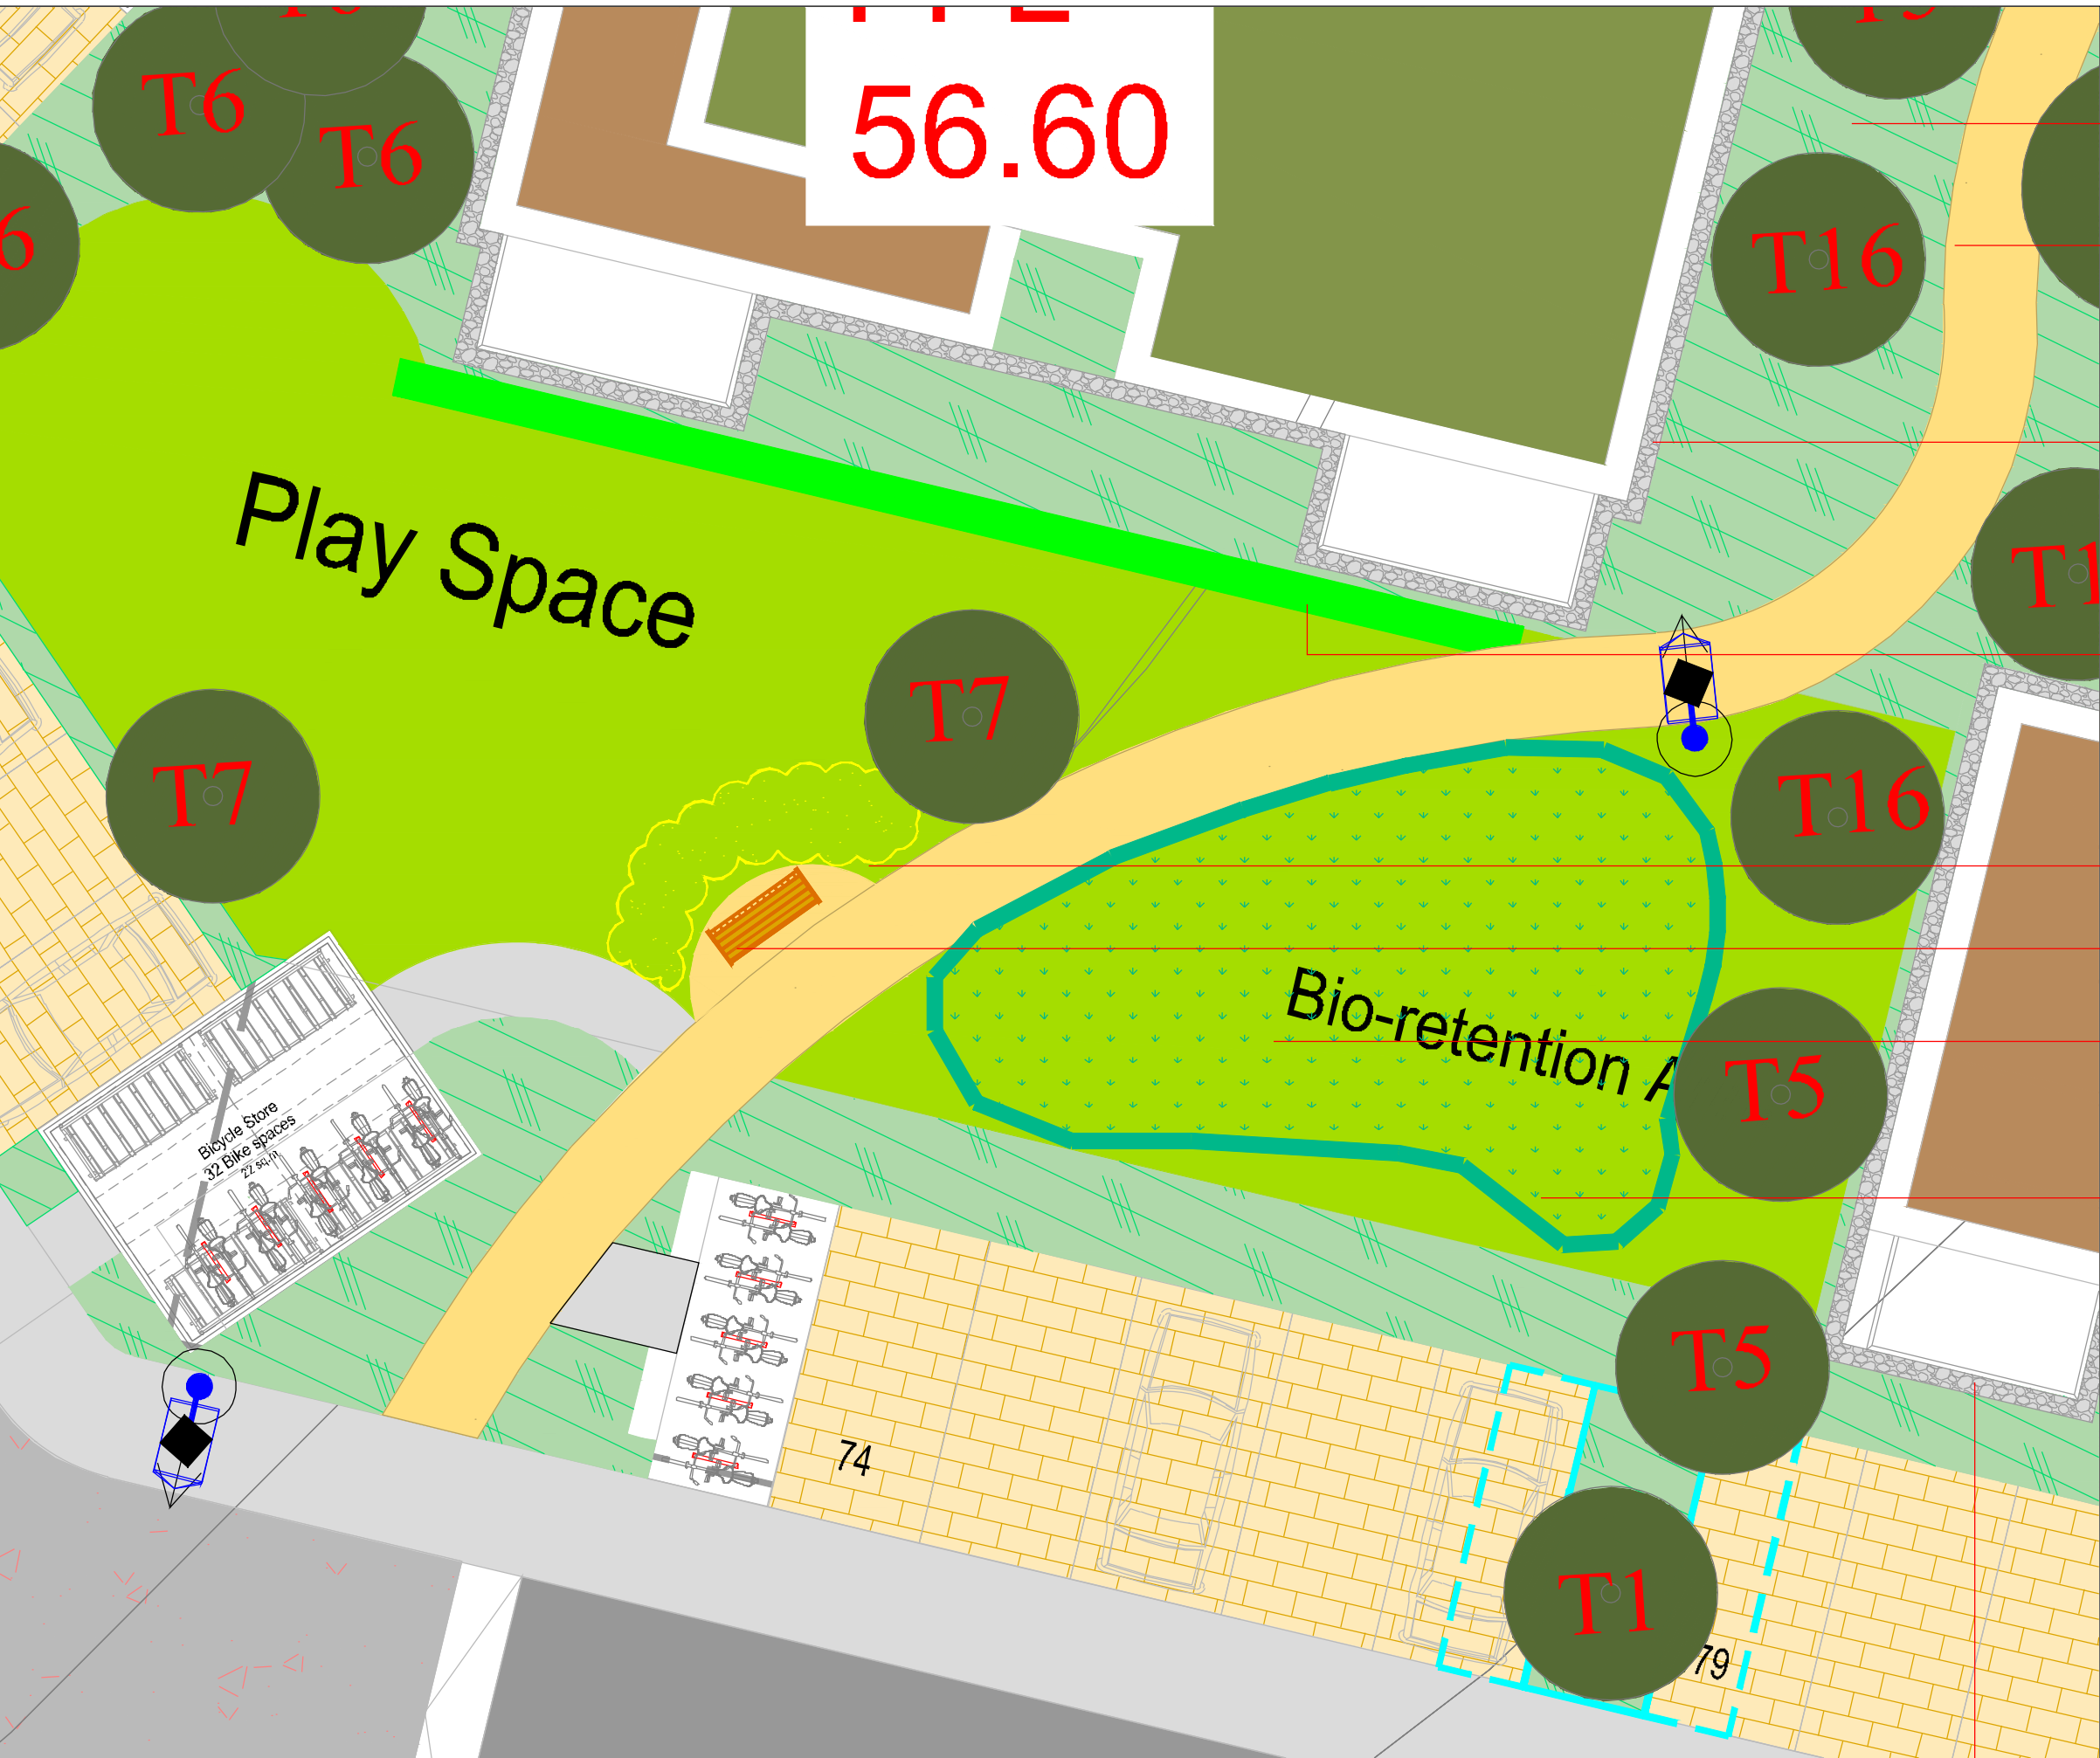


- Defensible Shrub Planting Against Building
- Path - Tarmacadam/Dust
- 300mm wide Gravel Drain between Building & Planting
- Hedge Planting - Prunus lusitanica to provide Defensible Planting
- Bulb Planting
- Seating Area
- Swale
- Outline of Underground Tank. See Engineers Dwgs.


Location Plan Scale 1:1000 @A1

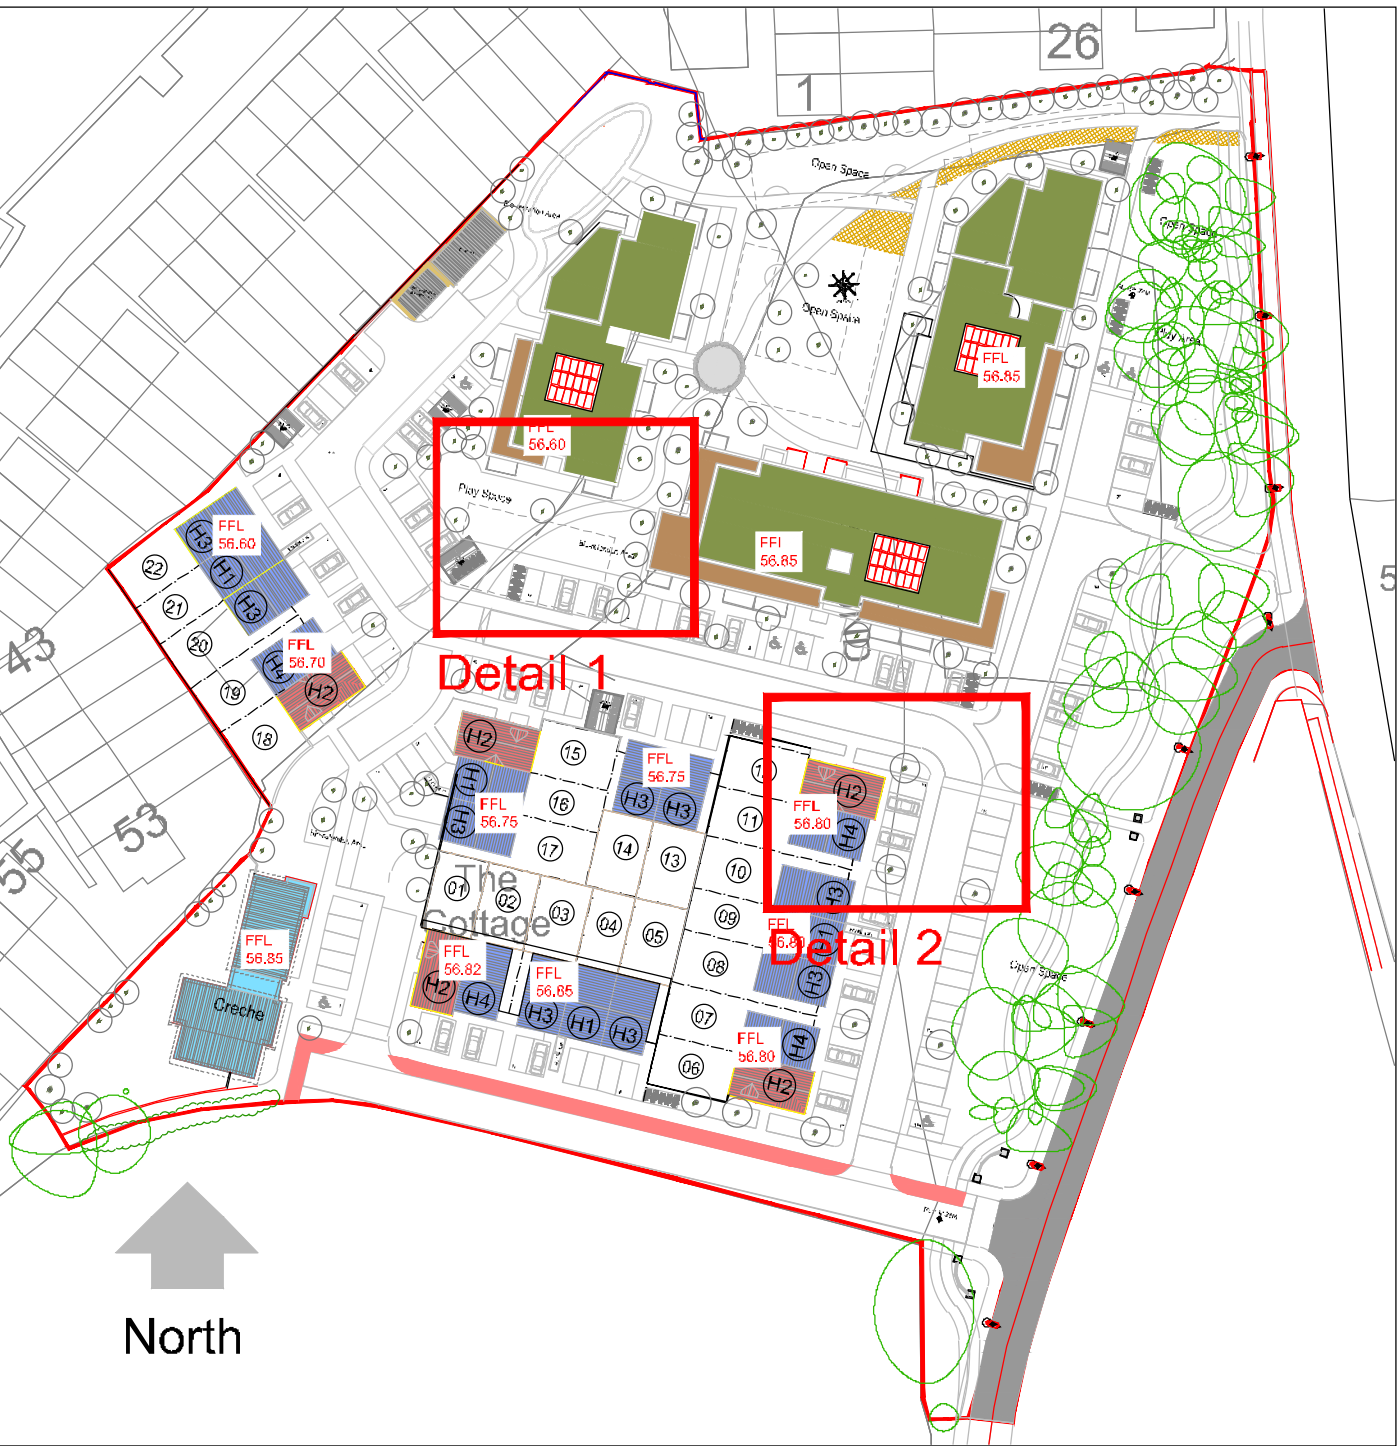

Gravel Drain Detail Scale 1:10 @A1

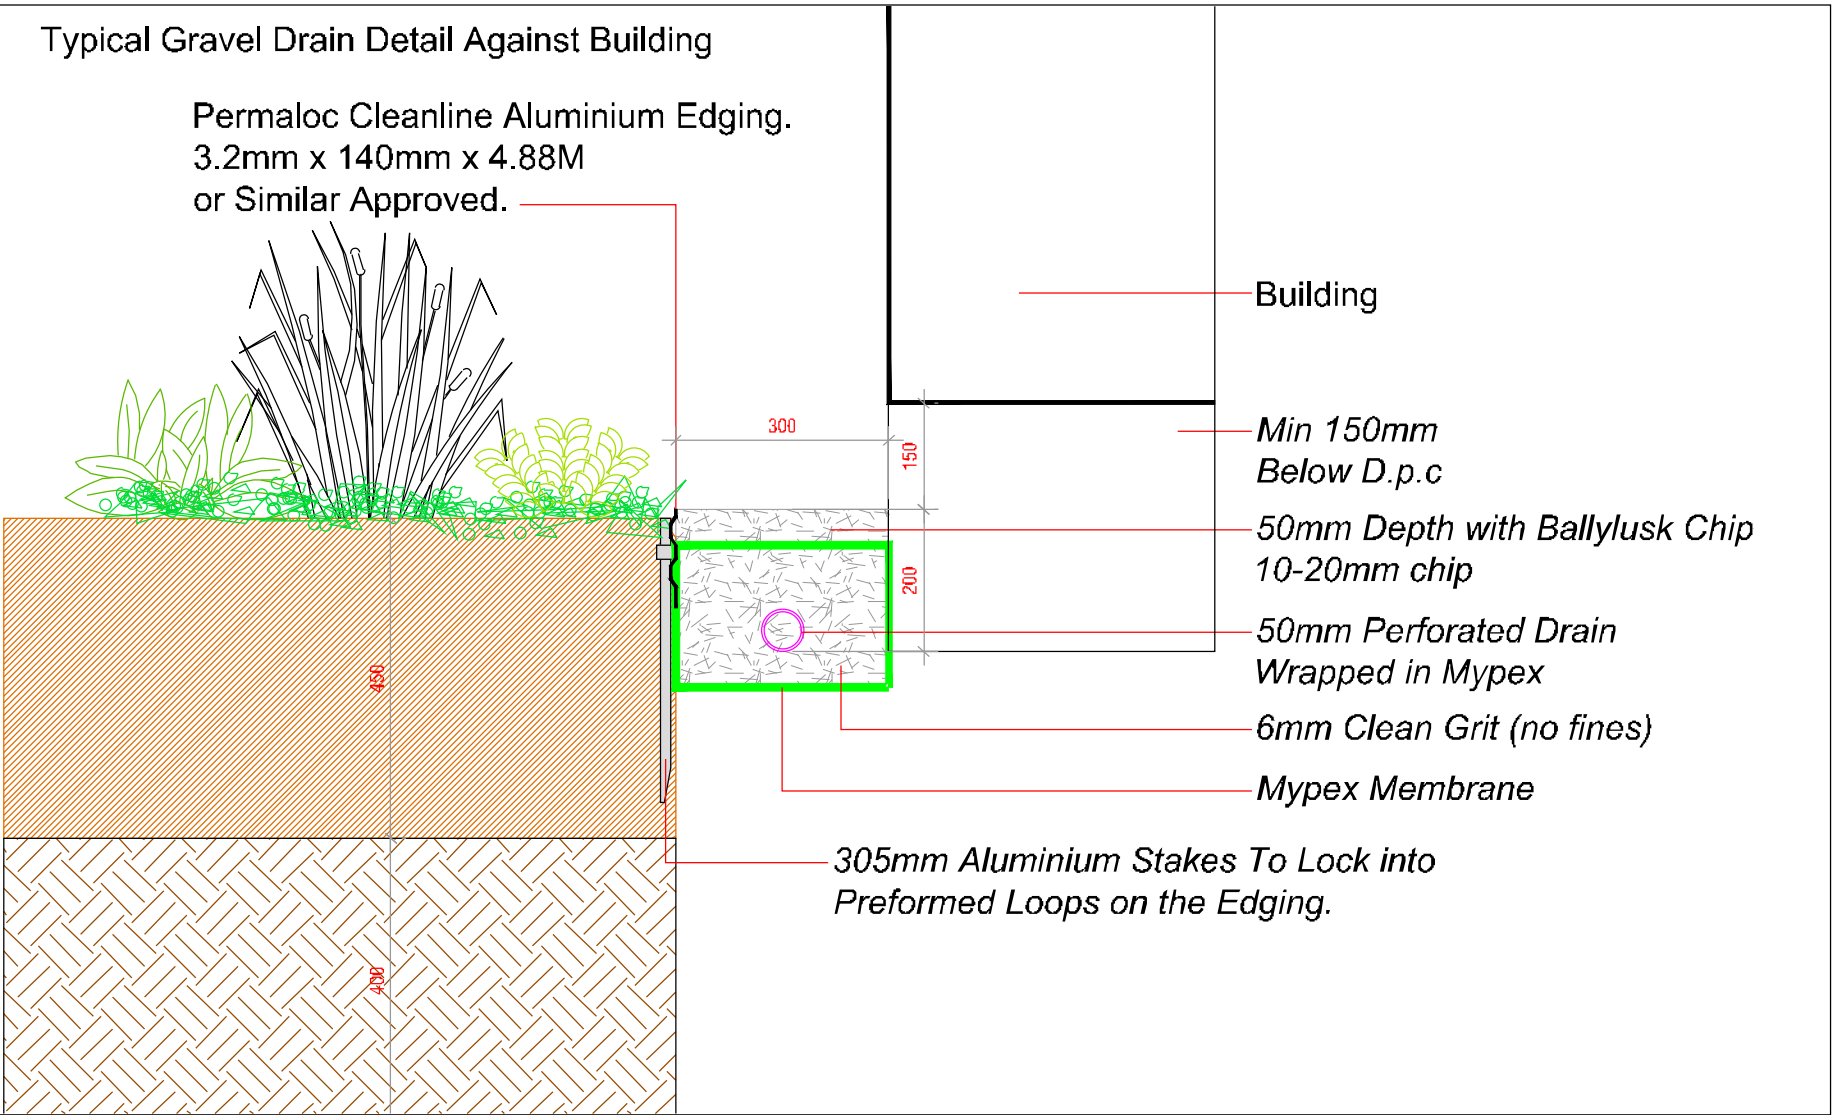


Hedge Detail Scale 1:10 @A1

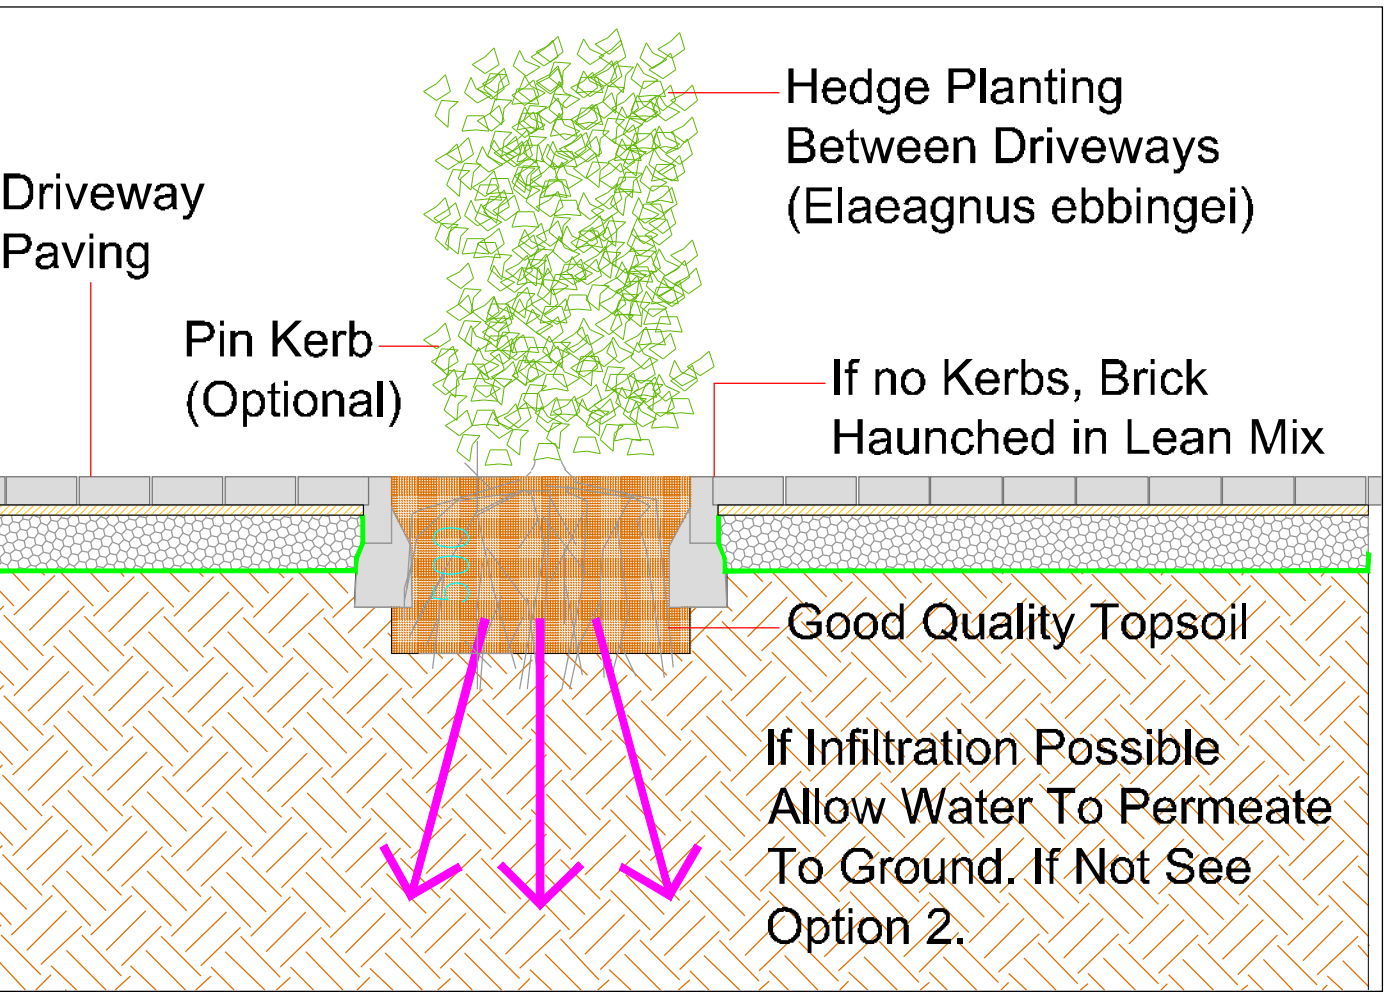


- Tree Planting - Acer campestre 'Elsrijk'
- Hedge Planting - Prunus lusitanica
- 1.2M High Railing (3 Bar)
- Carparking - Rustic Paving 200 x 100 x 80mm or similar Approved
- Natural Grey Paving 200 x 100 x 80mm or similar Approved
- Concrete Path

Detail 2 - House Front Detail Scale 1:100 @A1

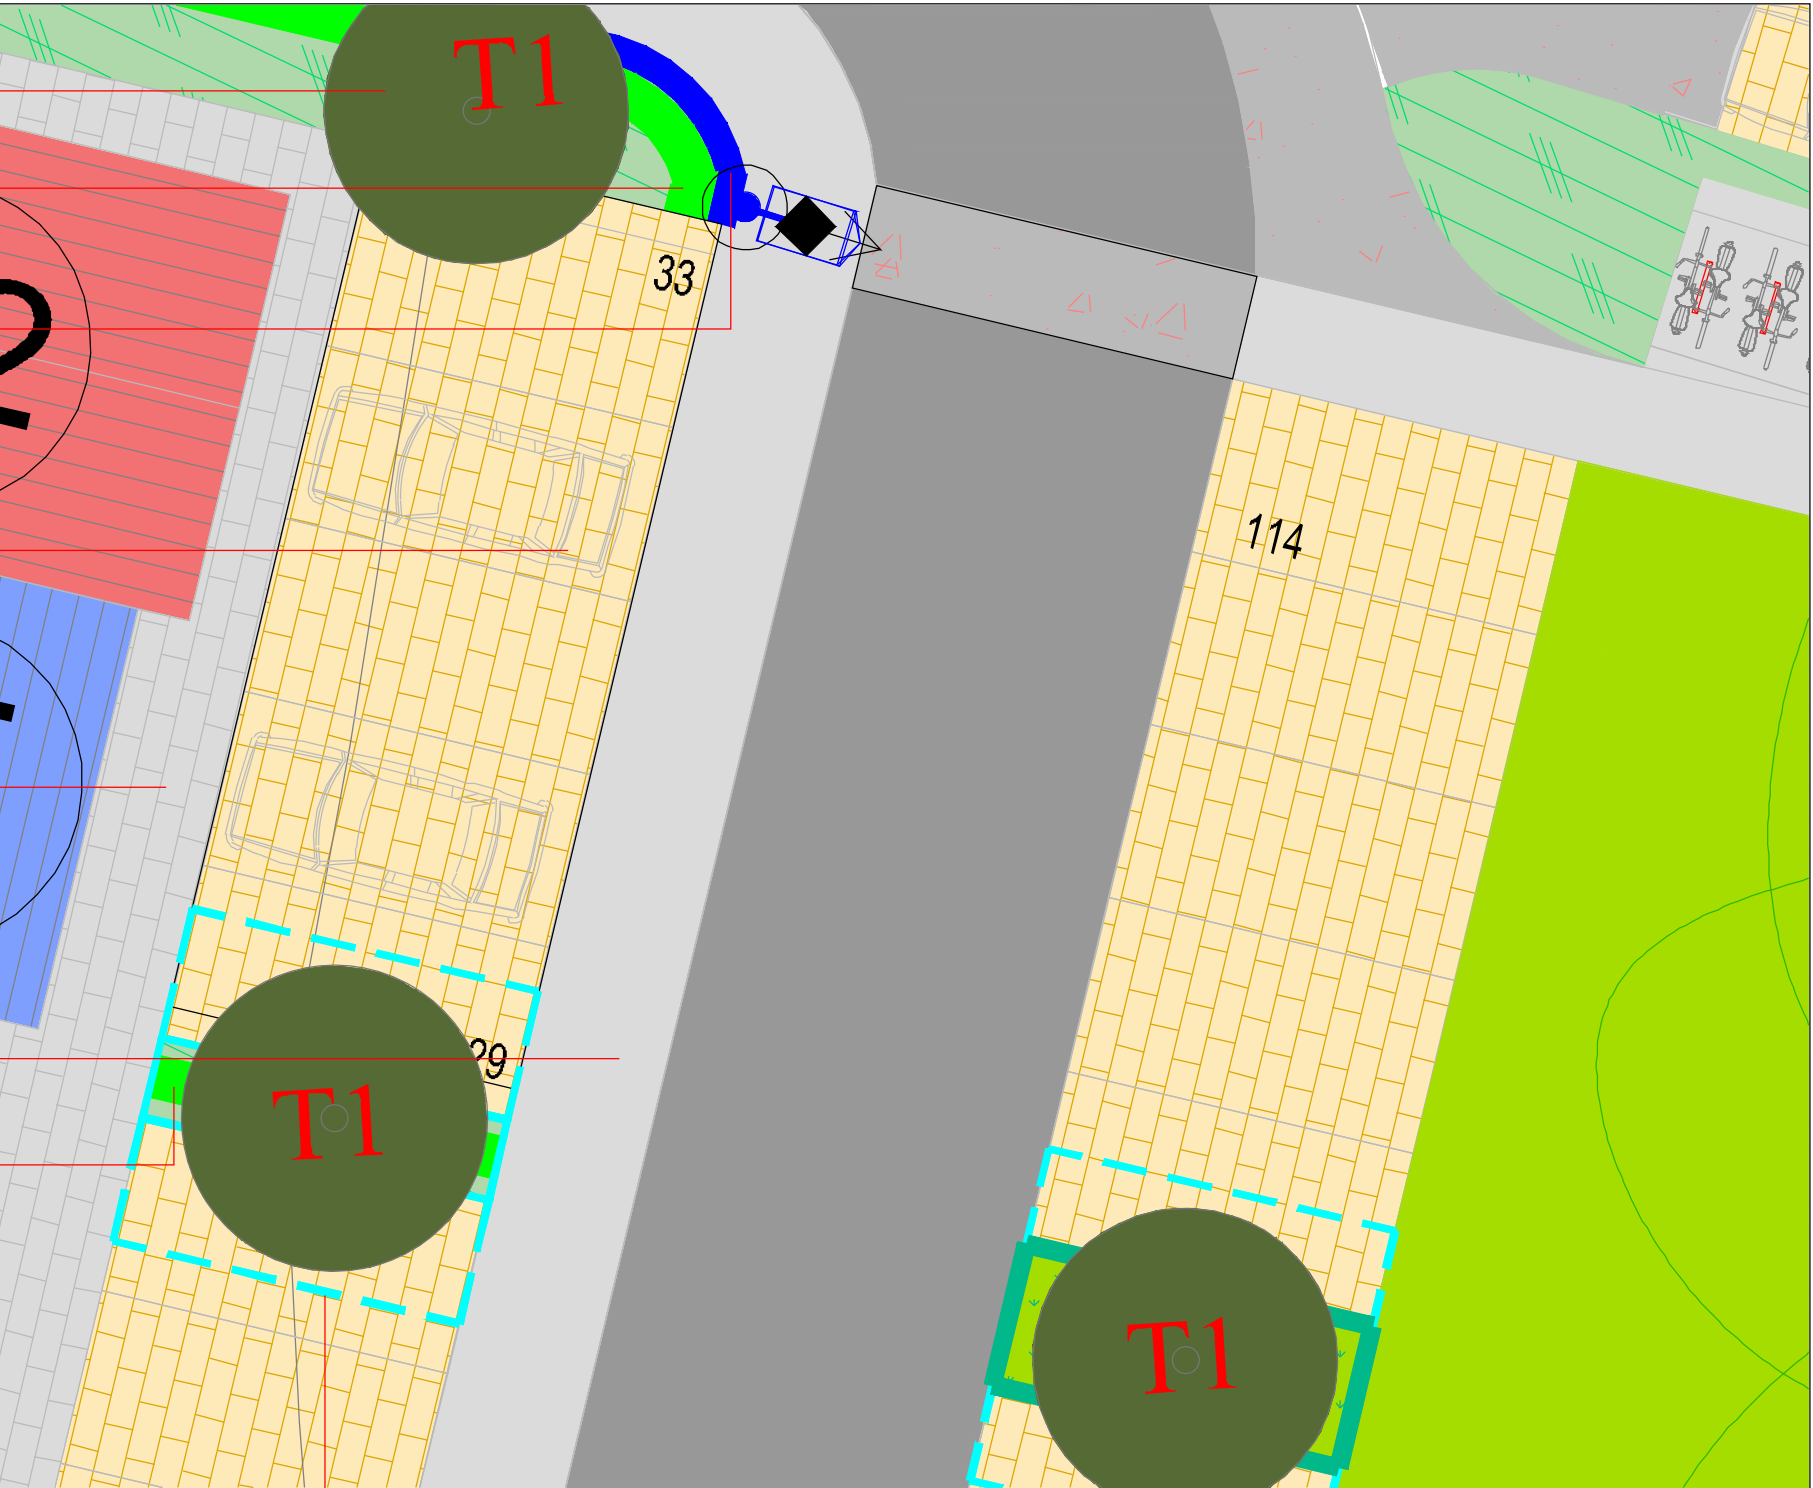

Urban Tree Pit location (See Dwg.09)

REVISIONS:				Project Title:	Dwg. No.:
Rev A	AMT	13-09-21	Revisions From Architects	Residential Development at Glencarrig, Celbridge, Co. Kildare.	03
Rev B	AMT	06-10-21	Revisions From Architects		Scale: As shown @ A1
Rev B1	AMT	26-10-21	Tank Locations From Engineers		
Rev B2	AMT	29-10-21	Revisions From Engineers	Client: Garyron Homes Ltd.	Date: 20.07.2021
Rev C	AMT	15-11-21	Updates to Road at Entrance & Arborist Revisions		
Rev D	AMT	04-05-22	Engineers Revisions, Sections Showing Crib Wall.	Drawing Title: Landscape Details	Drawing By: AMT
Rev E	AMT	09-05-22	Lighting Layout & Architects updates		Checked By: RMD
Rev F	AMT	21-07-22	LRD Application	Job No.: 1580	
Rev G	AMT	15-08-22	Lighting Revisions		
				 <div>Ronan MacDiarmada + Associates Ltd. Landscape Architects and Consultants. 5 Tootenhill, Rathcoole, Co. Dublin tel: +353 1 412 4476 mob: 086 26 25 438 fax: +353 1 401 3748 e-mail: ronan@rmda.ie</div>	
					This drawing is copyright ©