



Elevation A-AA - Western Boundary Treatment (Scale 1:25)

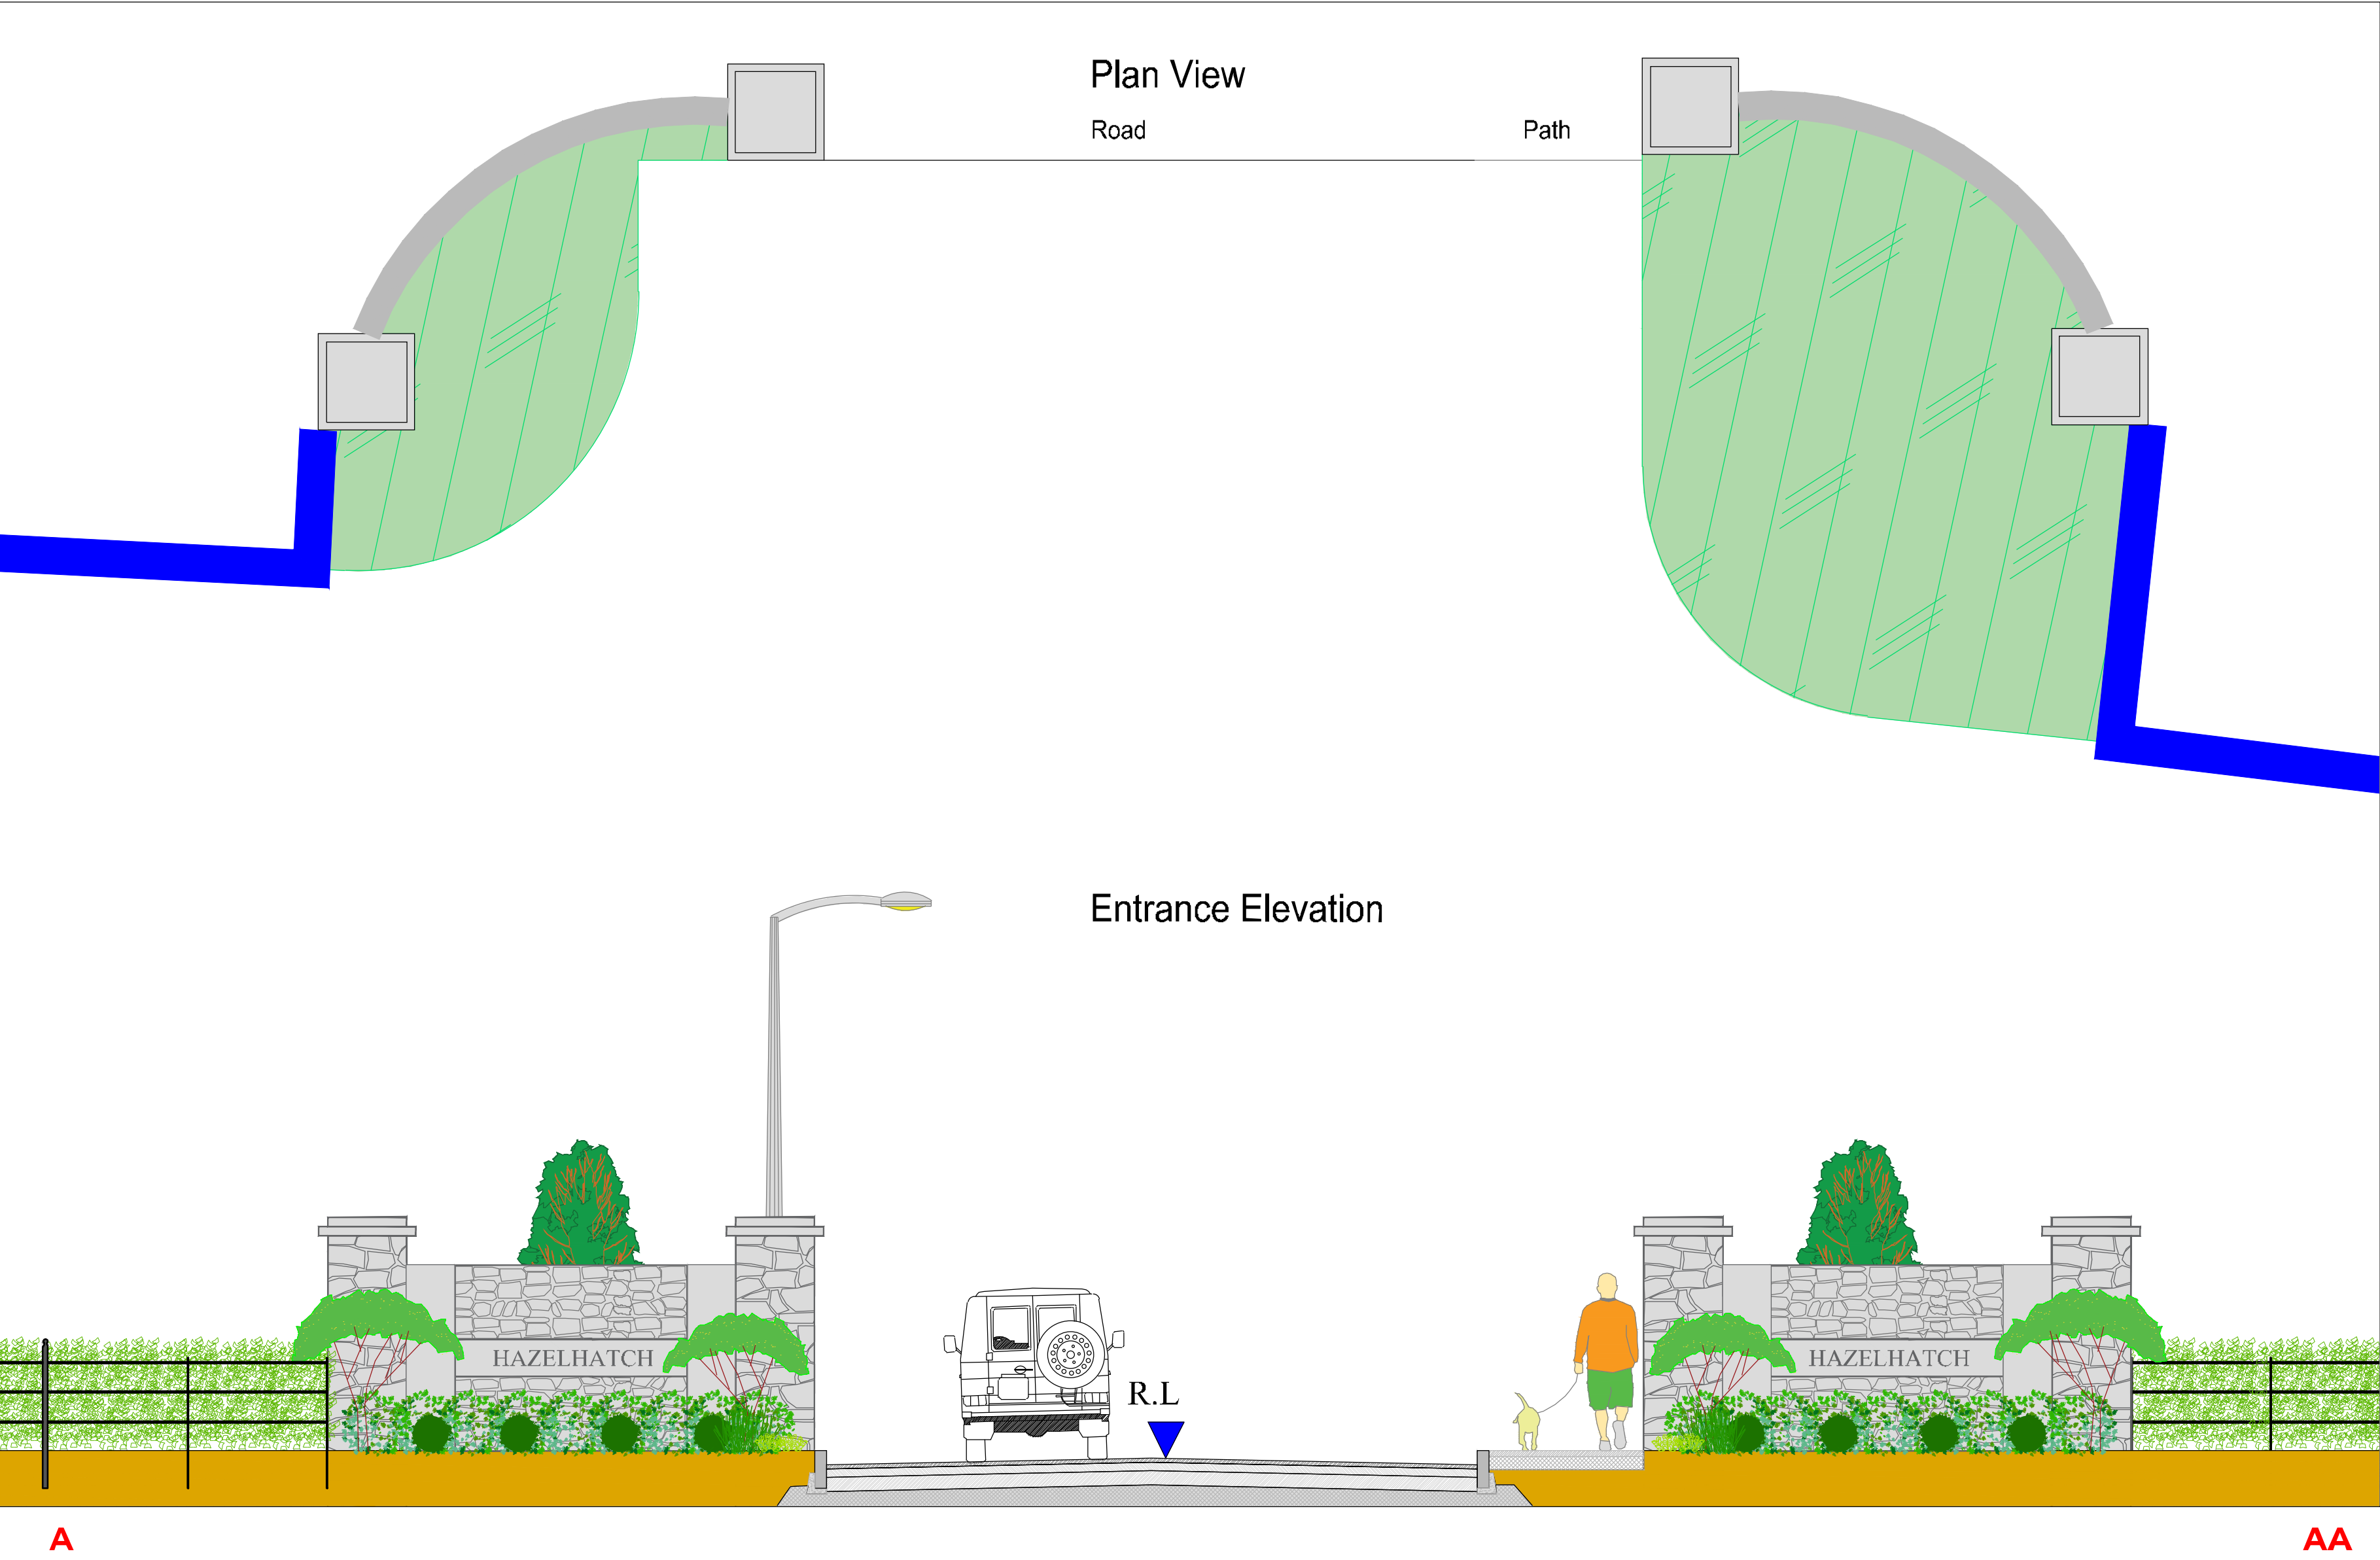

Location Plan Scale 1:1000 @A1



Elevation B-BB - Western Boundary Pedestrian Access (Scale 1:25)

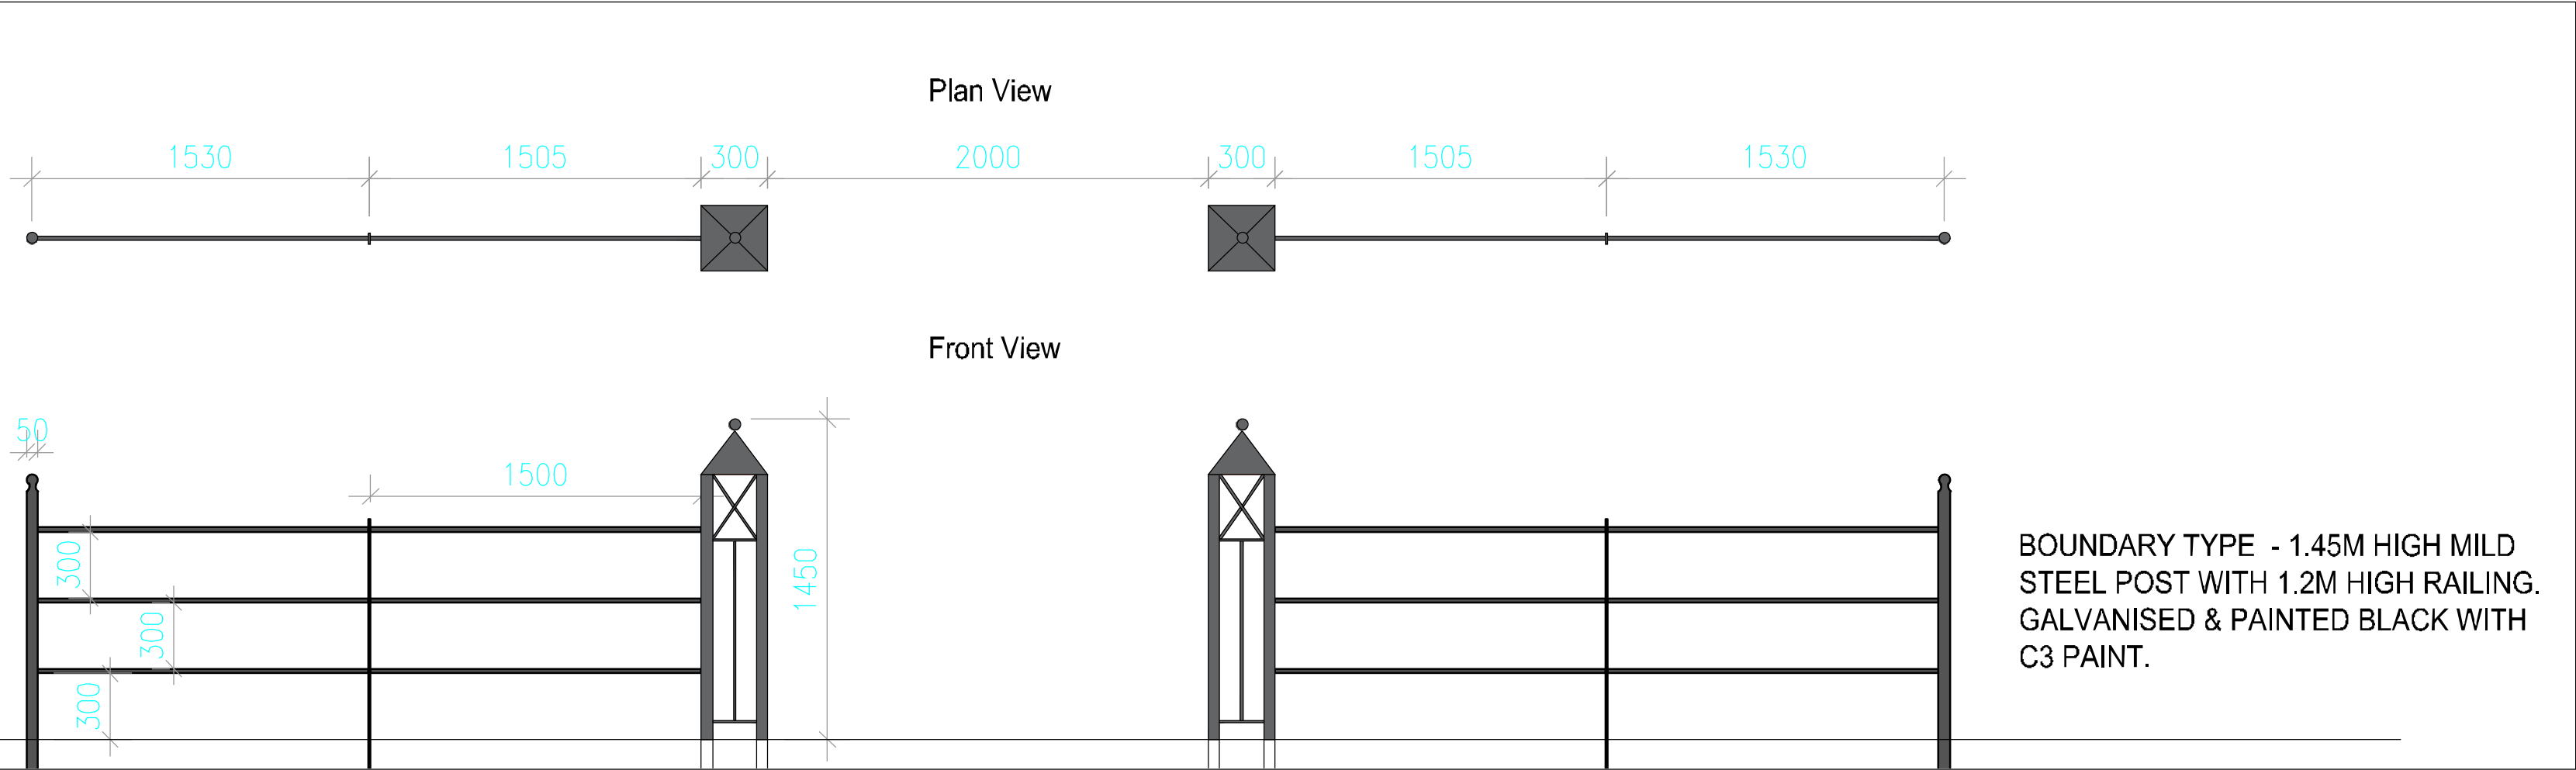

| REVISIONS: |     |          |                                                  | Project Title:                                                                                                                                                                                                                                                                                                          | Dwg. No.:            |
|------------|-----|----------|--------------------------------------------------|-------------------------------------------------------------------------------------------------------------------------------------------------------------------------------------------------------------------------------------------------------------------------------------------------------------------------|----------------------|
| Rev A      | AMT | 13-09-21 | Revisions From Architects                        | Residential Development at Glencarrig, Celbridge, Co. Kildare.                                                                                                                                                                                                                                                          | 07                   |
| Rev B      | AMT | 06-10-21 | Revisions From Architects                        |                                                                                                                                                                                                                                                                                                                         | Scale: As shown @ A1 |
| Rev B1     | AMT | 26-10-21 | Tank Locations From Engineers                    | Client: Garyson Homes Ltd.                                                                                                                                                                                                                                                                                              | Date: 20.07.2021     |
| Rev B2     | AMT | 29-10-21 | Revisions From Engineers                         |                                                                                                                                                                                                                                                                                                                         |                      |
| Rev C      | AMT | 15-11-21 | Updates to Road at Entrance & Arbonist Revisions | Drawing Title: Boundary Treatment Elevations                                                                                                                                                                                                                                                                            | Drawing By: AMT      |
| Rev D      | AMT | 04-05-22 | Engineers Revisions, Sections Showing Crib Wall. | Job No.: 1580                                                                                                                                                                                                                                                                                                           | Checked By: RMD      |
| Rev E      | AMT | 09-05-22 | Lighting Layout & Architects updates             | <div><b>Ronan MacDiarmada + Associates Ltd.</b><br/>Landscape Architects and Consultants.<br/>5 Tootenhill, Rathcoole, Co. Dublin<br/>tel: +353 1 412 4476 mob: 086 26 25 438<br/>fax: +353 1 401 3748 e-mail: ronan@rmda.ie</div> |                      |
| Rev F      | AMT | 21-07-22 | LRD Application                                  |                                                                                                                                                                                                                                                                                                                         |                      |
| Rev G      | AMT | 15-08-22 | Lighting Revisions                               | This drawing is copyright ©                                                                                                                                                                                                                                                                                             |                      |